


INDIANA UNIVERSITY EAST BRICE E. HAYES HALL RENOVATIONS TO ROOMS 099, 135, 137, & 140 IU PROJECT #: 20170750

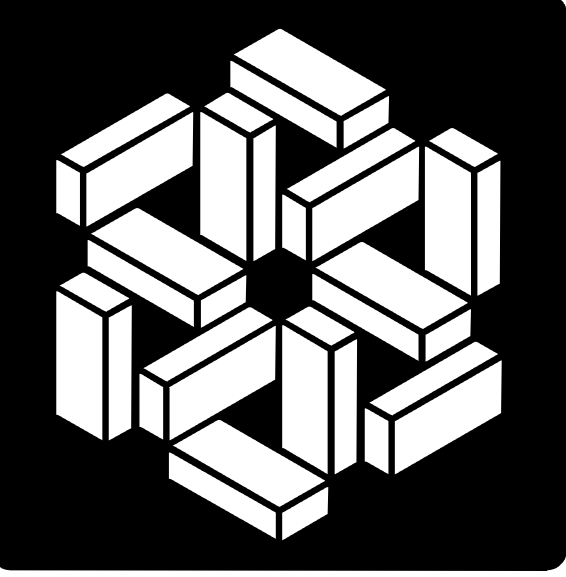

**MSKTD
& Associates**

Architecture | Engineering | Interior Design

1715 Magnavox Way Fort Wayne, IN 46804 260.432.9337
930 North Meridian Indianapolis, IN 46204 317.917.1190
www.msktd.com




Drawing Index


- G1-1 Title Sheet
- A0-1 General Information
- A1-1 Demolition Plans
- A2-1 Floor Plans
- A5-1 Wall Sections and Details
- I2-1 Interior Finish Plans
- P2-1 Plumbing Plans
- M2-1 Mechanical Plans
- E1-1 Electrical Demo Plans
- E2-1 Electrical Plans

Contacts

- | | |
|---|--|
| <p>Architectural:
Gary Voiron
MSKTD & Associates
gev@msktd.com
260.432.9337</p> <p>Interiors:
Amber Kolkman
MSKTD & Associates
alk@msktd.com
260.432.9337</p> | <p>Mechanical & Plumbing:
Mike Nichter
MSKTD & Associates
mdn@msktd.com
260.432.9337</p> <p>Electrical:
Kevin Fenn
MSKTD & Associates
kbf@msktd.com
260.432.9337</p> |
|---|--|

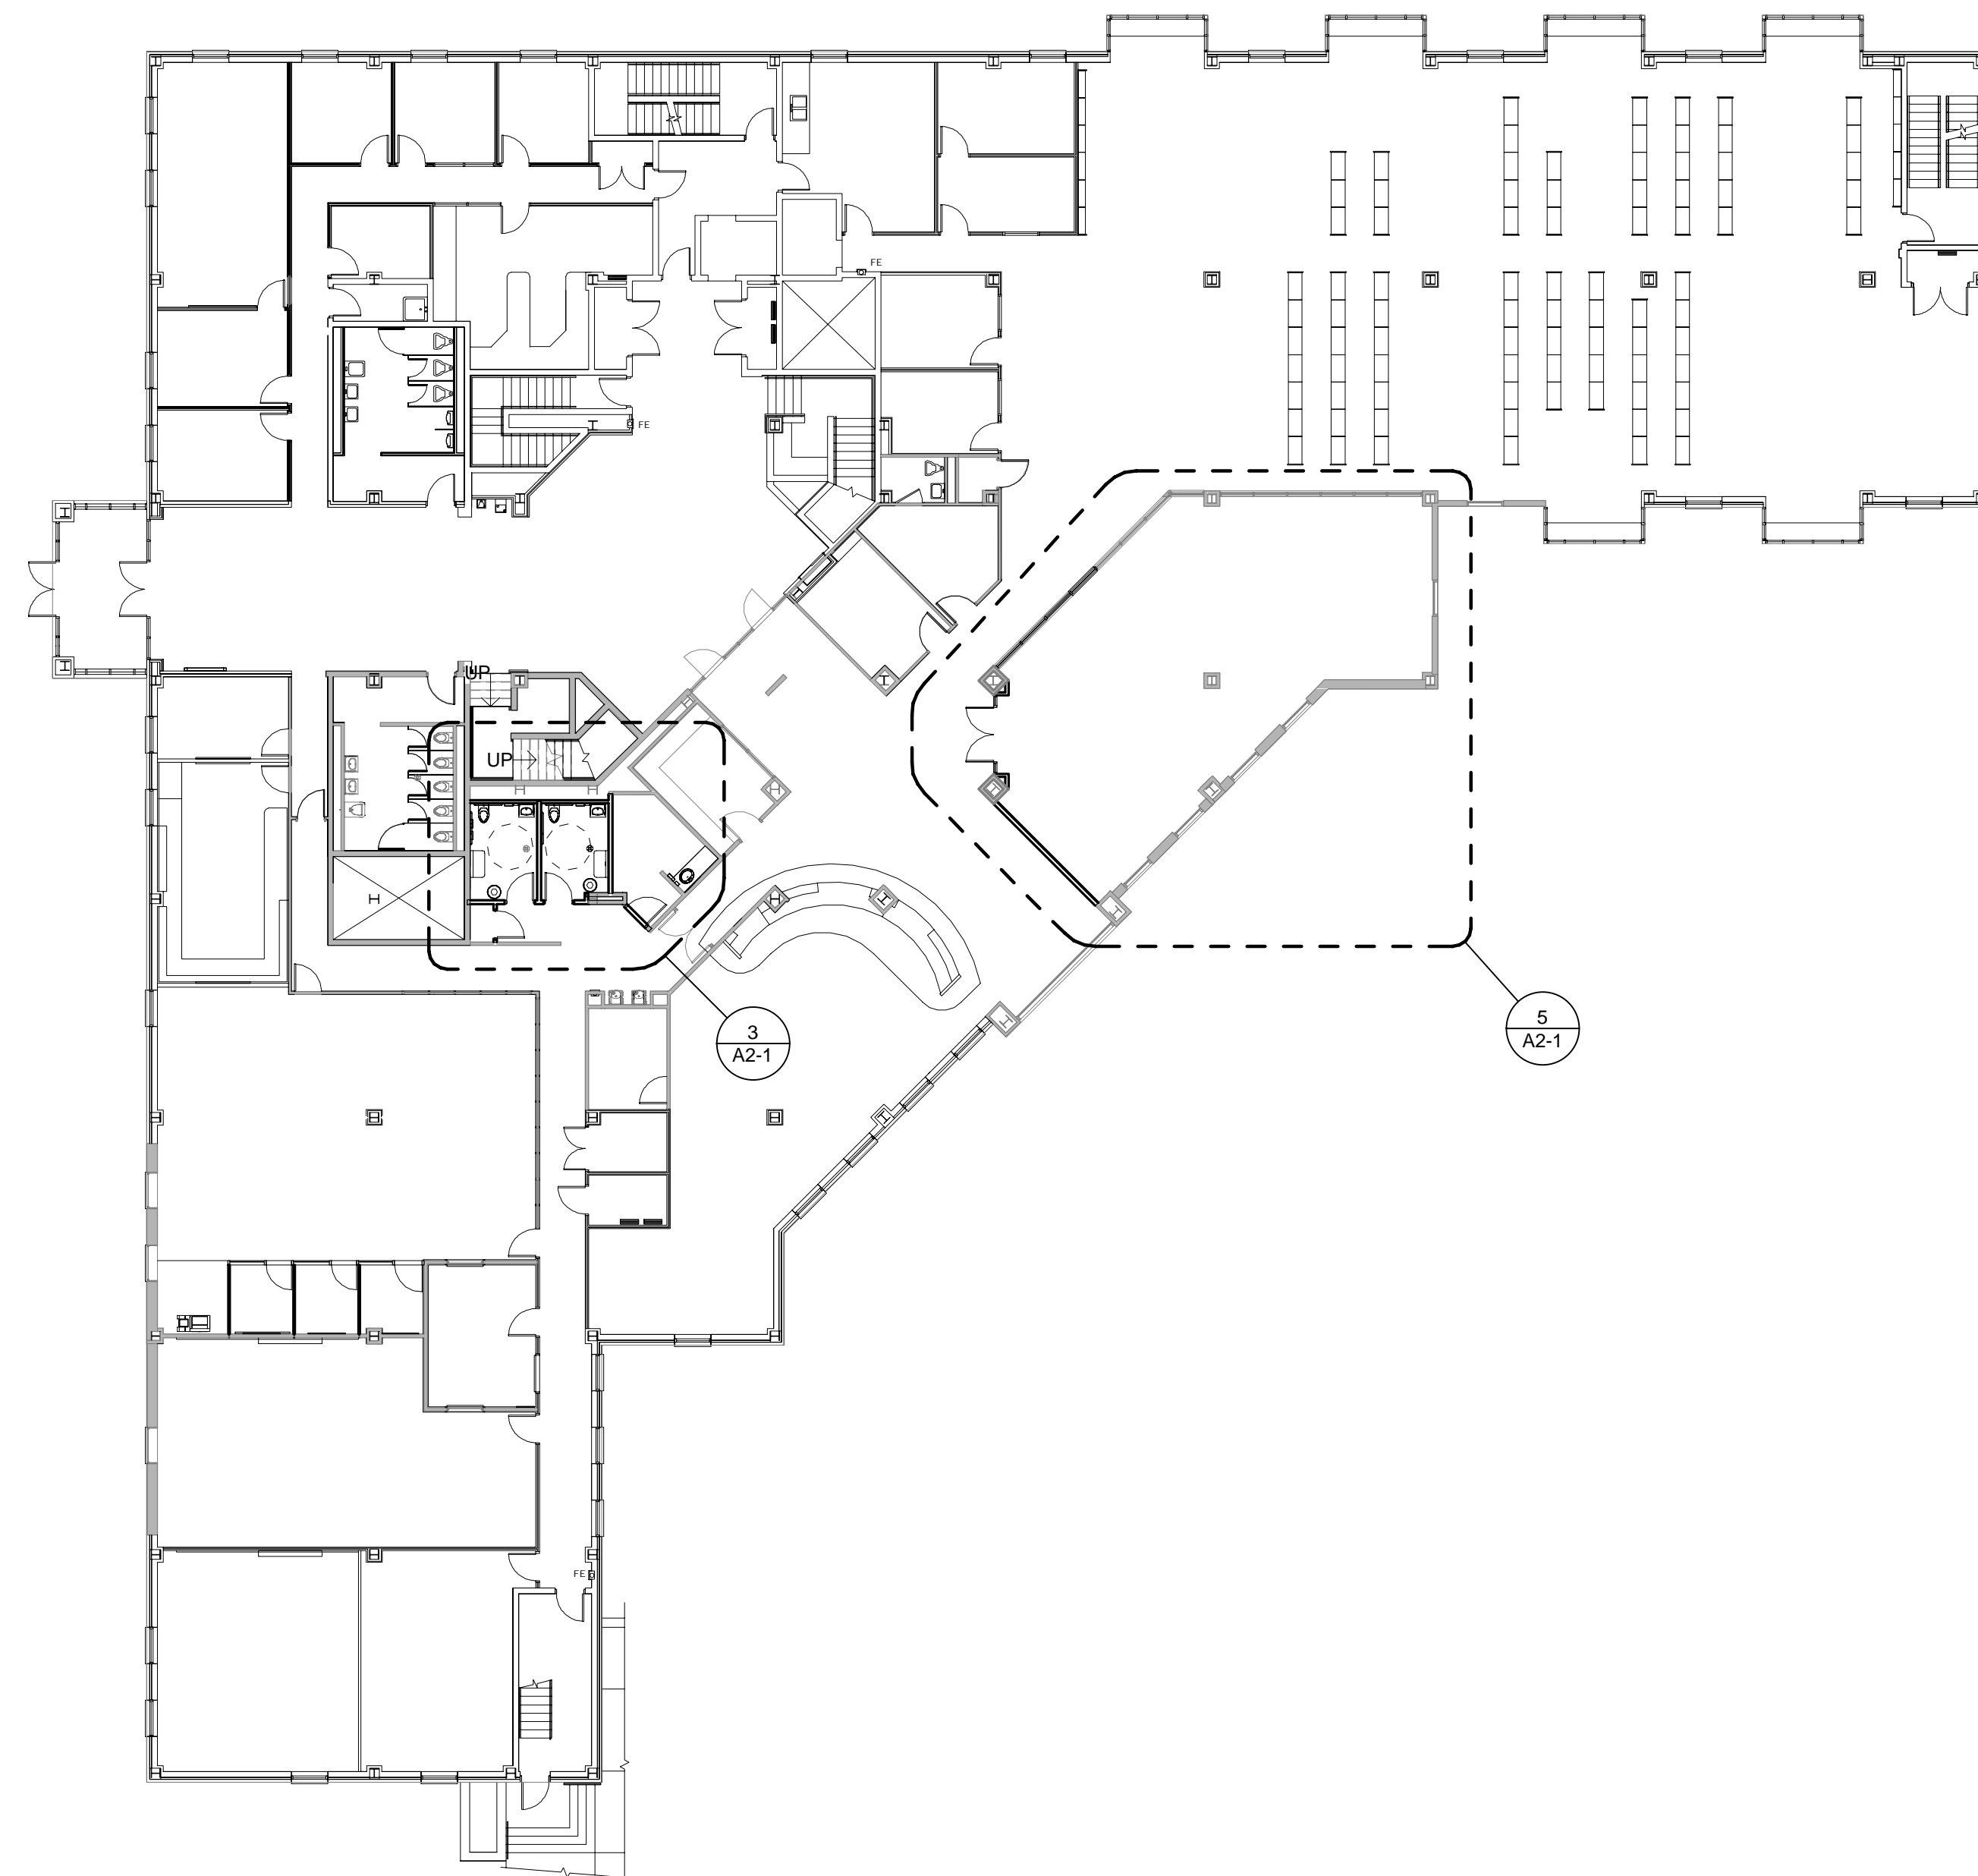

Overall First Floor Plan
1/16" = 1'-0"

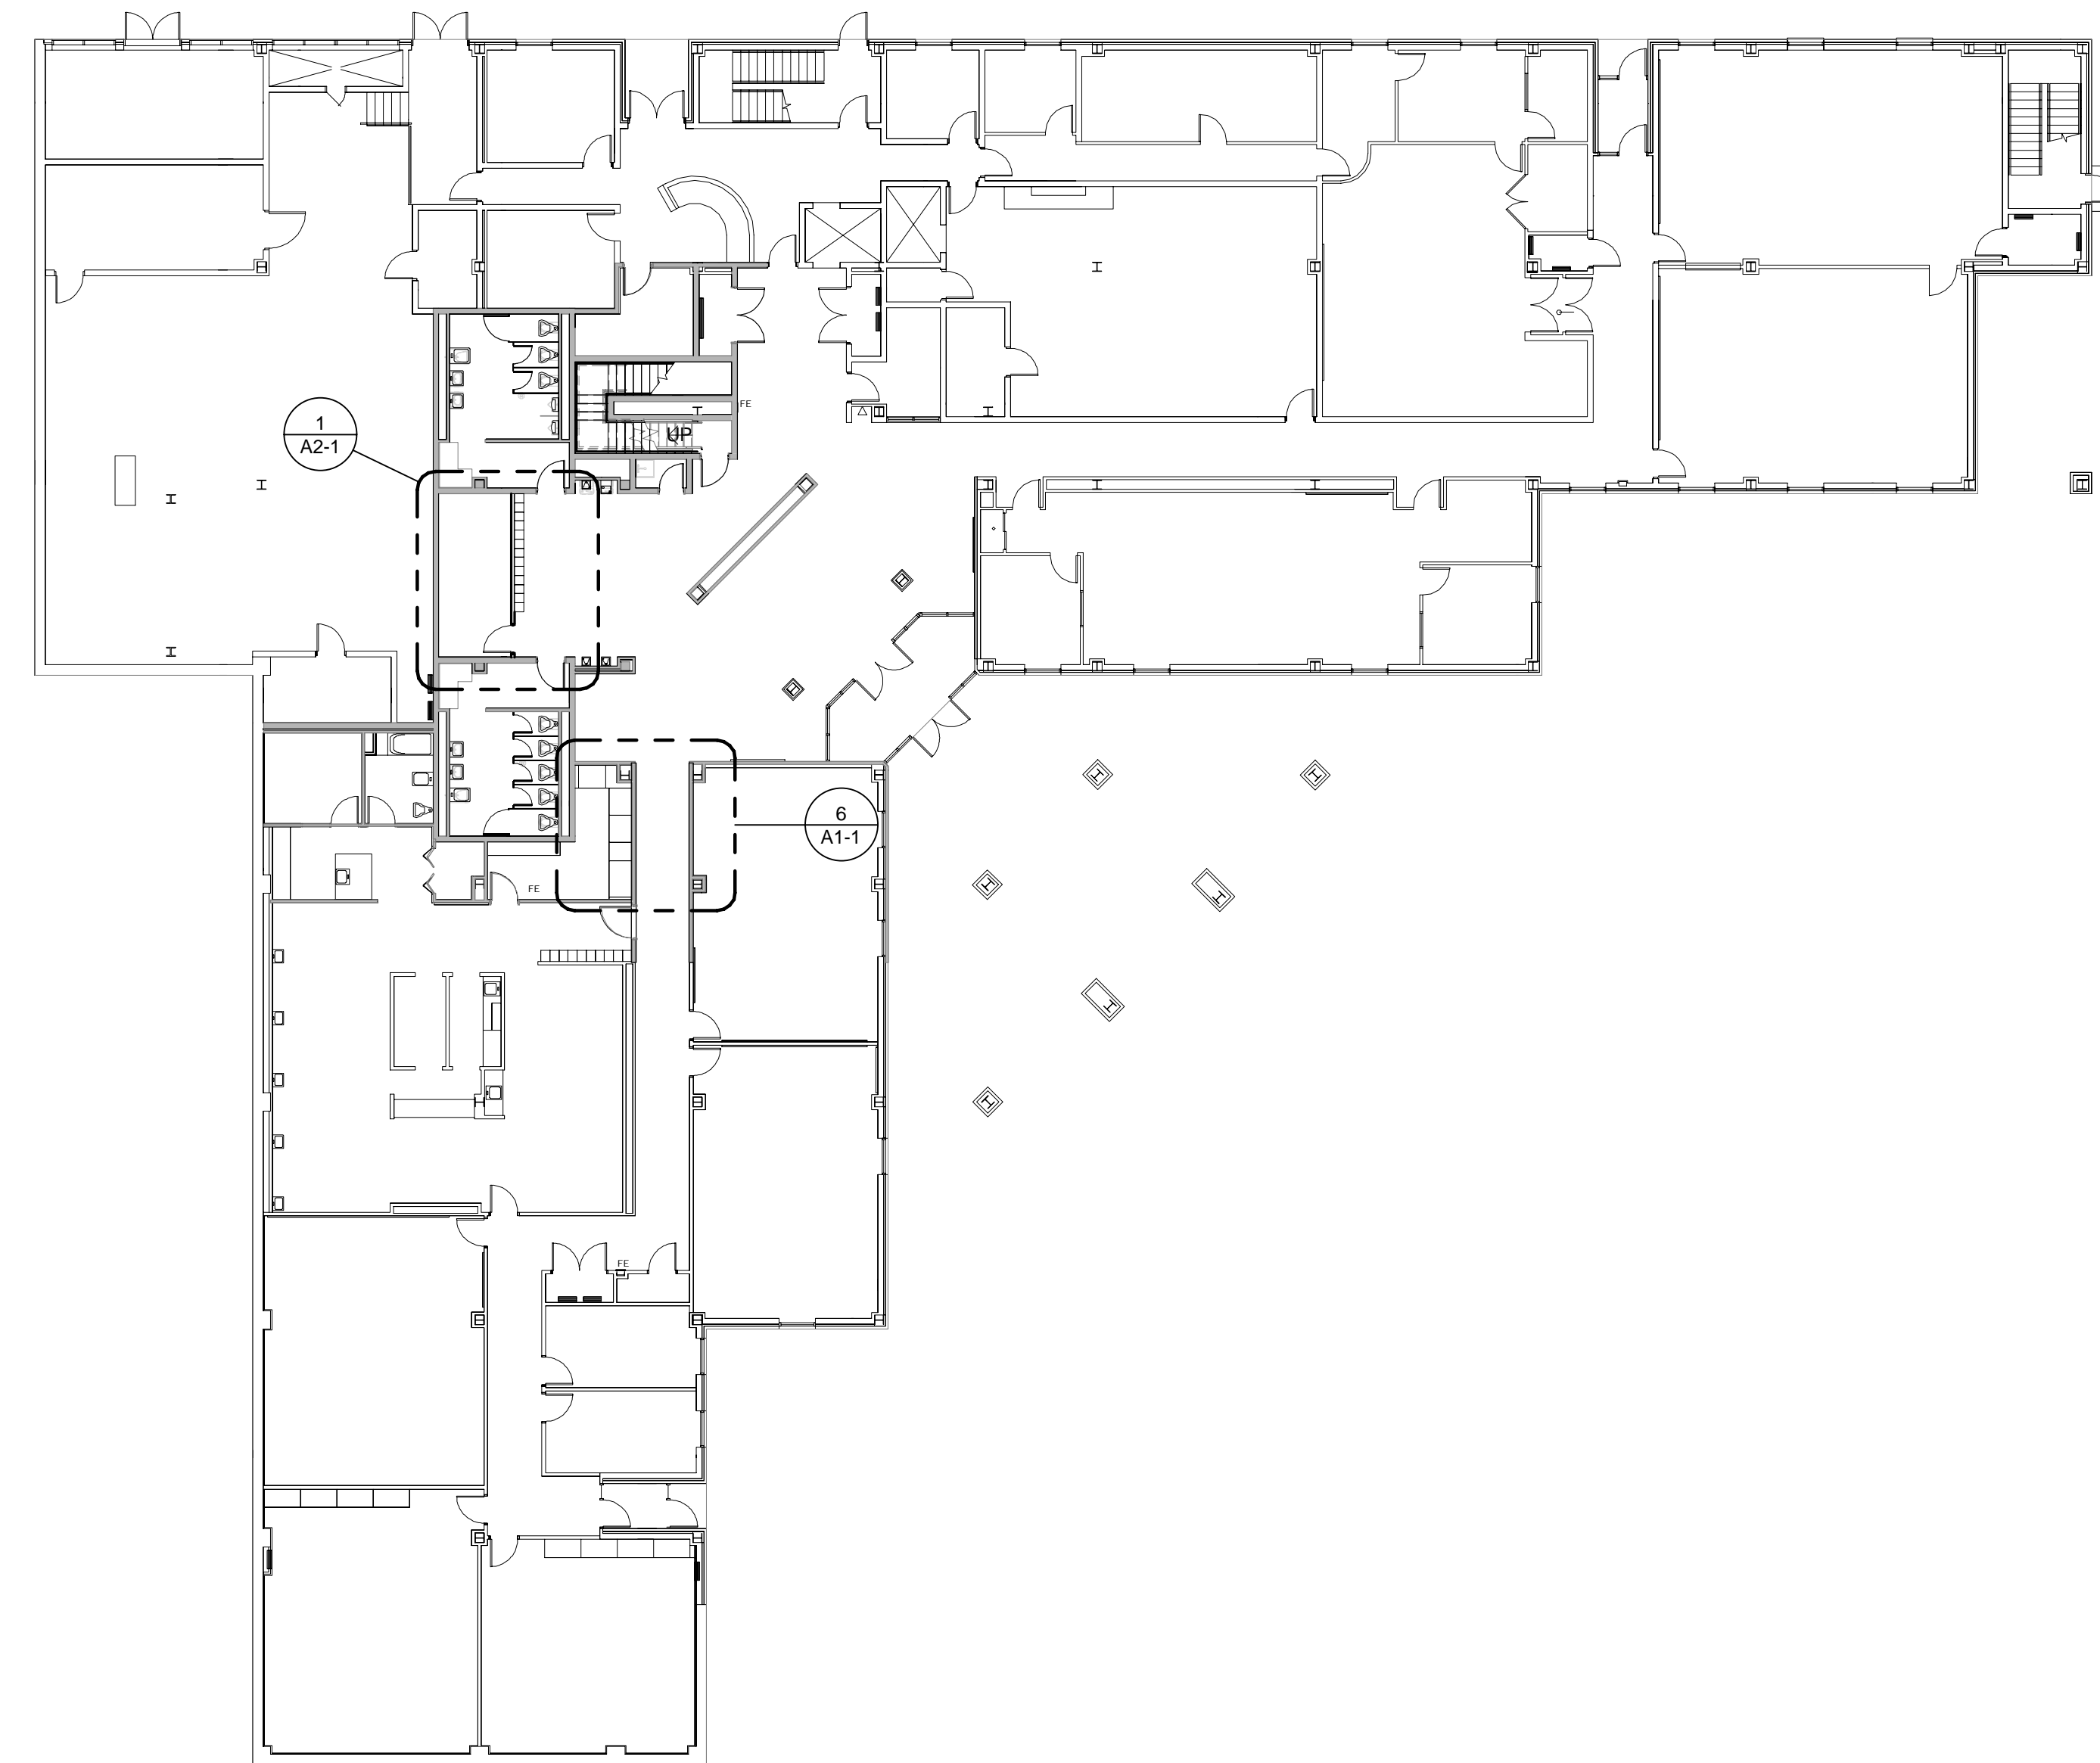

Overall Ground Floor Plan
1/16" = 1'-0"

A Project for:
Indiana University East
 Brice E. Hayes Hall
 Renovations to Rooms 099, 135, 137, & 140
 IU Project Number: 20170750

PROJECT NO. 7327	DATE 10-05-18
REV.	DATE

SET DESCRIPTION
Construction Set

SHEET TITLE
Title Sheet

SHEET NUMBER

G1-1