


MSKTD & Associates

Architecture | Engineering | Interior Design

1715 Magnavox Way Fort Wayne, IN 46804 260.432.8337
930 North Meridian Indianapolis, IN 46204 317.917.1190
www.msktd.com

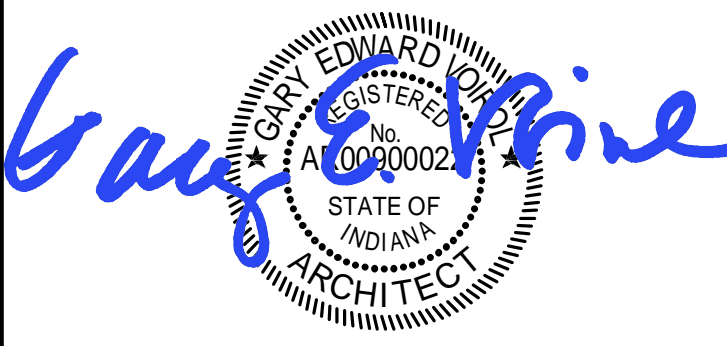


Specific Reflected Ceiling Plan Notes


RC2 | NEW CEILING AND GRID - SEE FINISH PLAN

Specific Demolition Plan Notes


- D1 | CONTRACTOR TO REMOVE LOCKERS AND RETURN TO OWNER
- D2 | REFRESH FLOORS WHERE EXISTING LOCKERS WERE LOCATED
- D3 | DEMO ALL EXISTING TOILET PARTITIONS
- D4 | GENERAL CONTRACTOR SHALL REMOVE OWNER EQUIPMENT NECESSARY TO SAW CUT FLOOR AS SHOWN. TEMPORARILY STORE AS NECESSARY. ALL AREAS SHALL BE MASKED OFF AND PROTECTED DURING SAW CUTTING. LOCATE AREAS TO BE REMOVED IN CONJUNCTION WITH PLUMBING CONTRACTOR. REMOVE ALL DEMOLISHED CONCRETE AND PATCH AFTER PLUMBING WORK IS COMPLETED. ALL FLOOR, BASE AND WALL FINISHED SHALL BE MATCHED BACK TO ORIGINAL CONDITIONS. NOTE: LOCATION OF EXISTING SANITARY PIPING IS TAKEN FROM DESIGN DRAWINGS. EXISTING PIPE LOCATIONS MIGHT BE IN DIFFERENT LOCATIONS. VERIFY IN FIELD.
- D5 | DEMO EXISTING WALL IN ITS ENTIRETY. PATCH ALL ADJACENT SURFACES. PREPARE FOR NEW CONSTRUCTION
- D6 | EXISTING PLUMBING FIXTURES TO BE REMOVED. SEE PLUMBING PLANS FOR ADDITIONAL INFORMATION
- D8 | PATCH EXISTING WALL WHERE HEATER WAS LOCATED. COORDINATE WITH MECHANICAL. PREPARE FOR NEW CONSTRUCTION
- D9 | REMOVE PORTION OF EXISTING CEILING TO INSTALL NEW WALL
- D10 | REMOVE DOOR AND FRAME. RETAIN DOOR FOR REINSTALLATION.
- D11 | DEMO EXISTING GYPSUM CEILING.

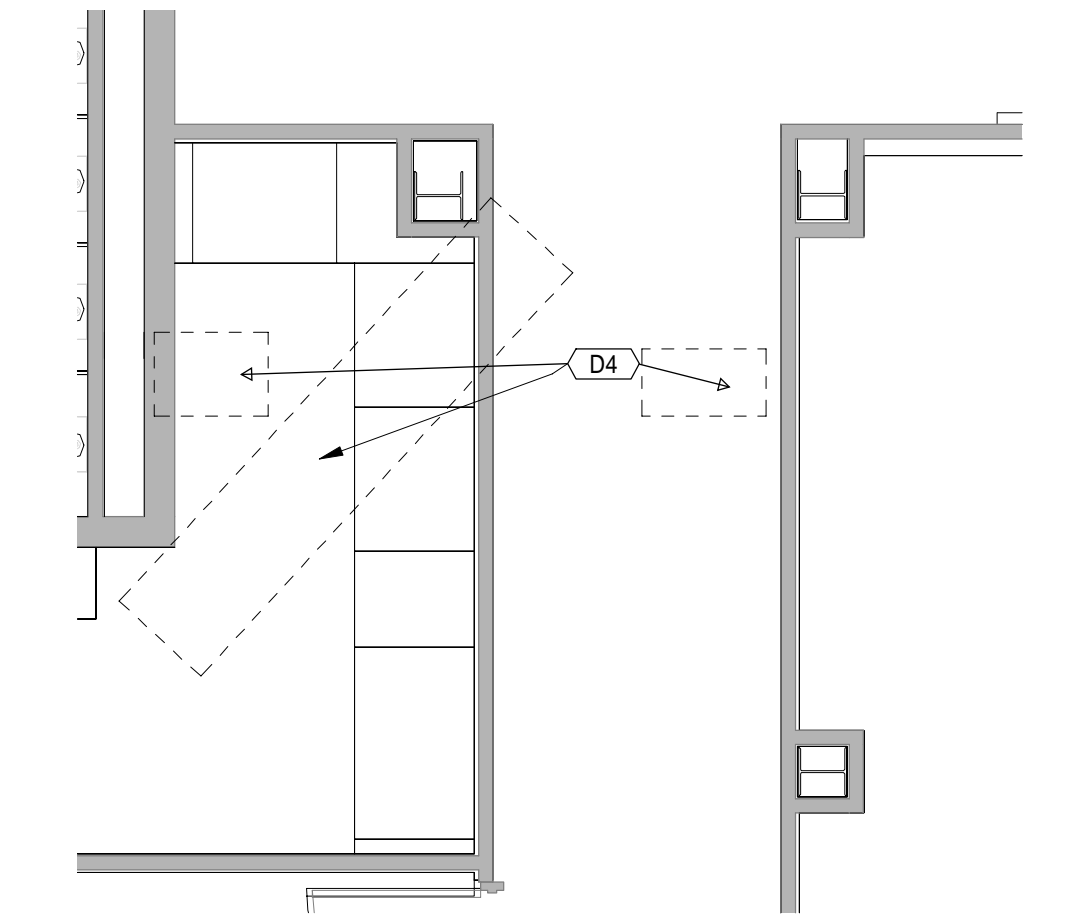


6 Ground Floor Plumbing Demo RCP
1/4" = 1'-0"

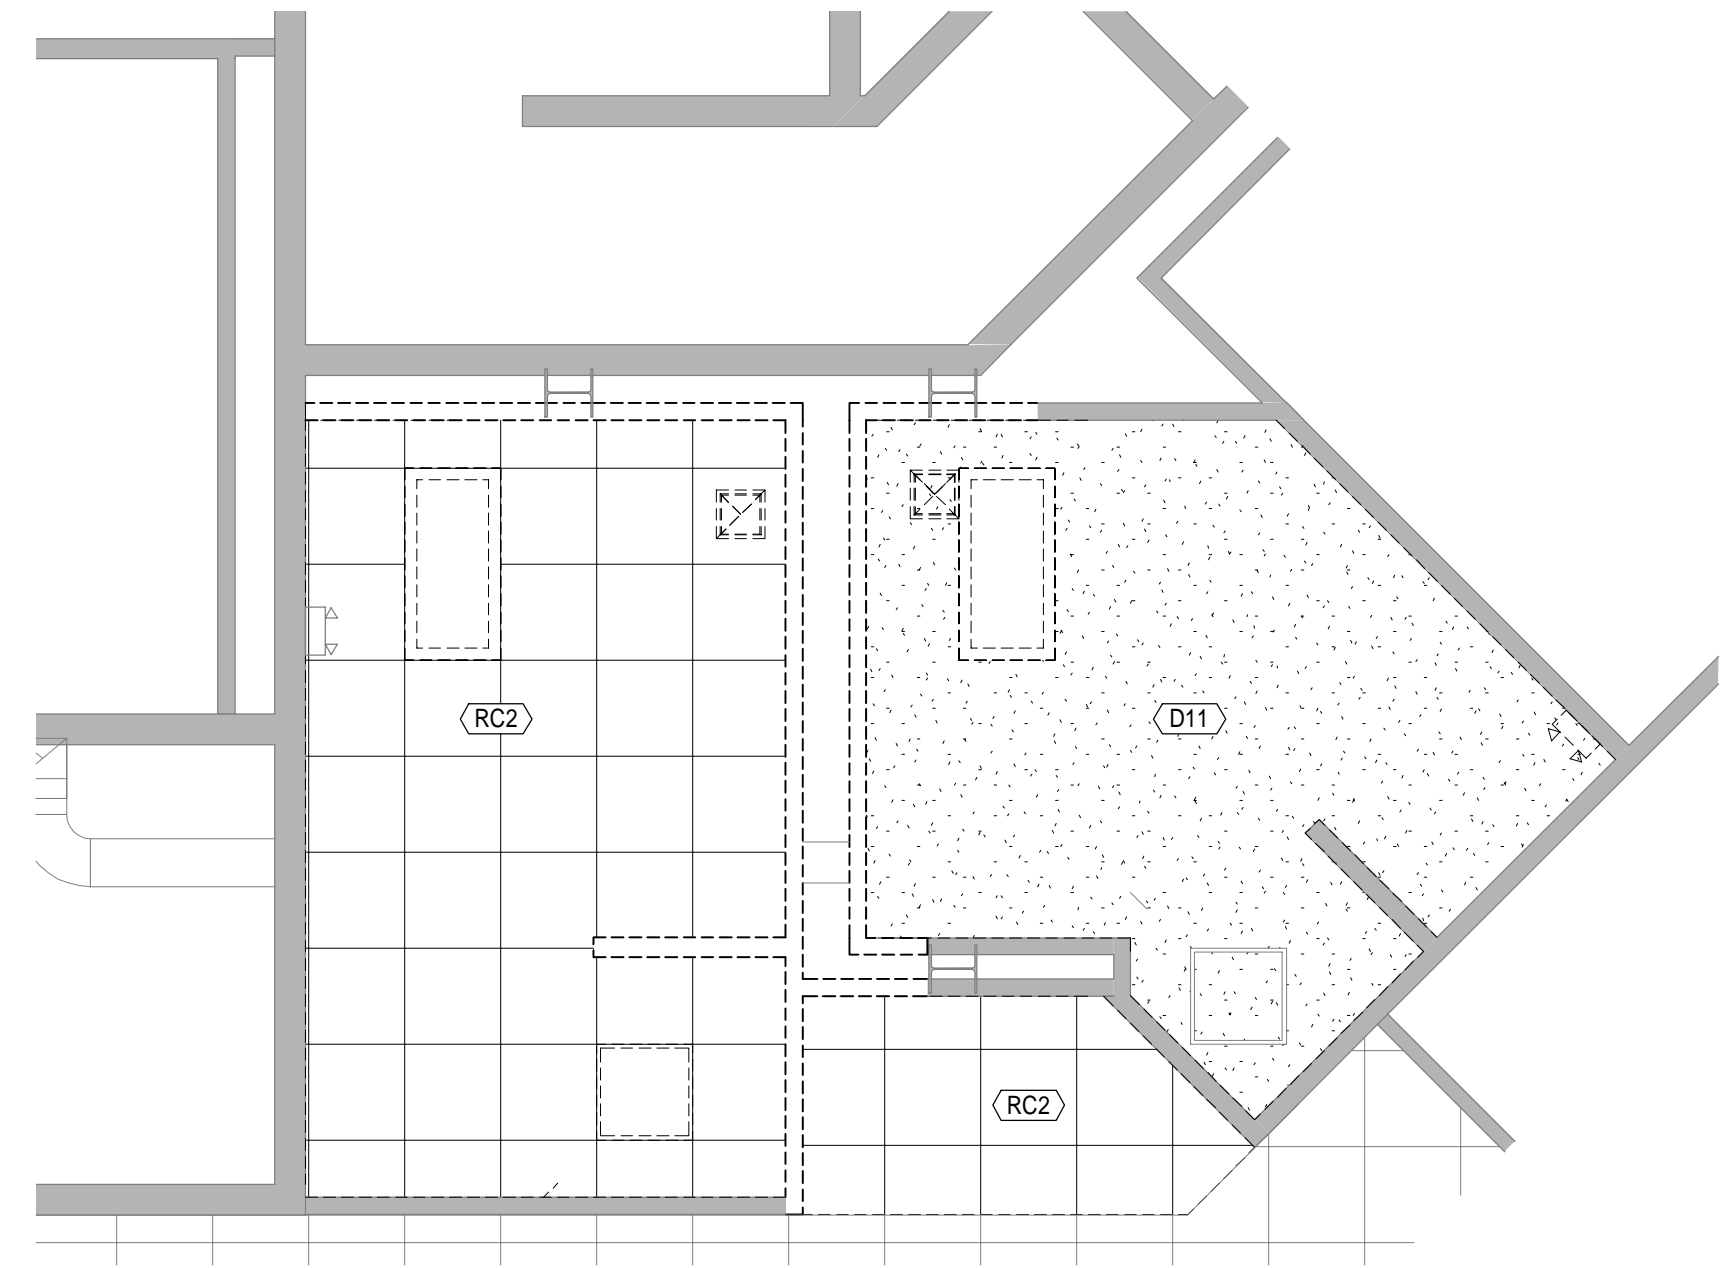


4 Wellness Area Demo RCP
1/4" = 1'-0"

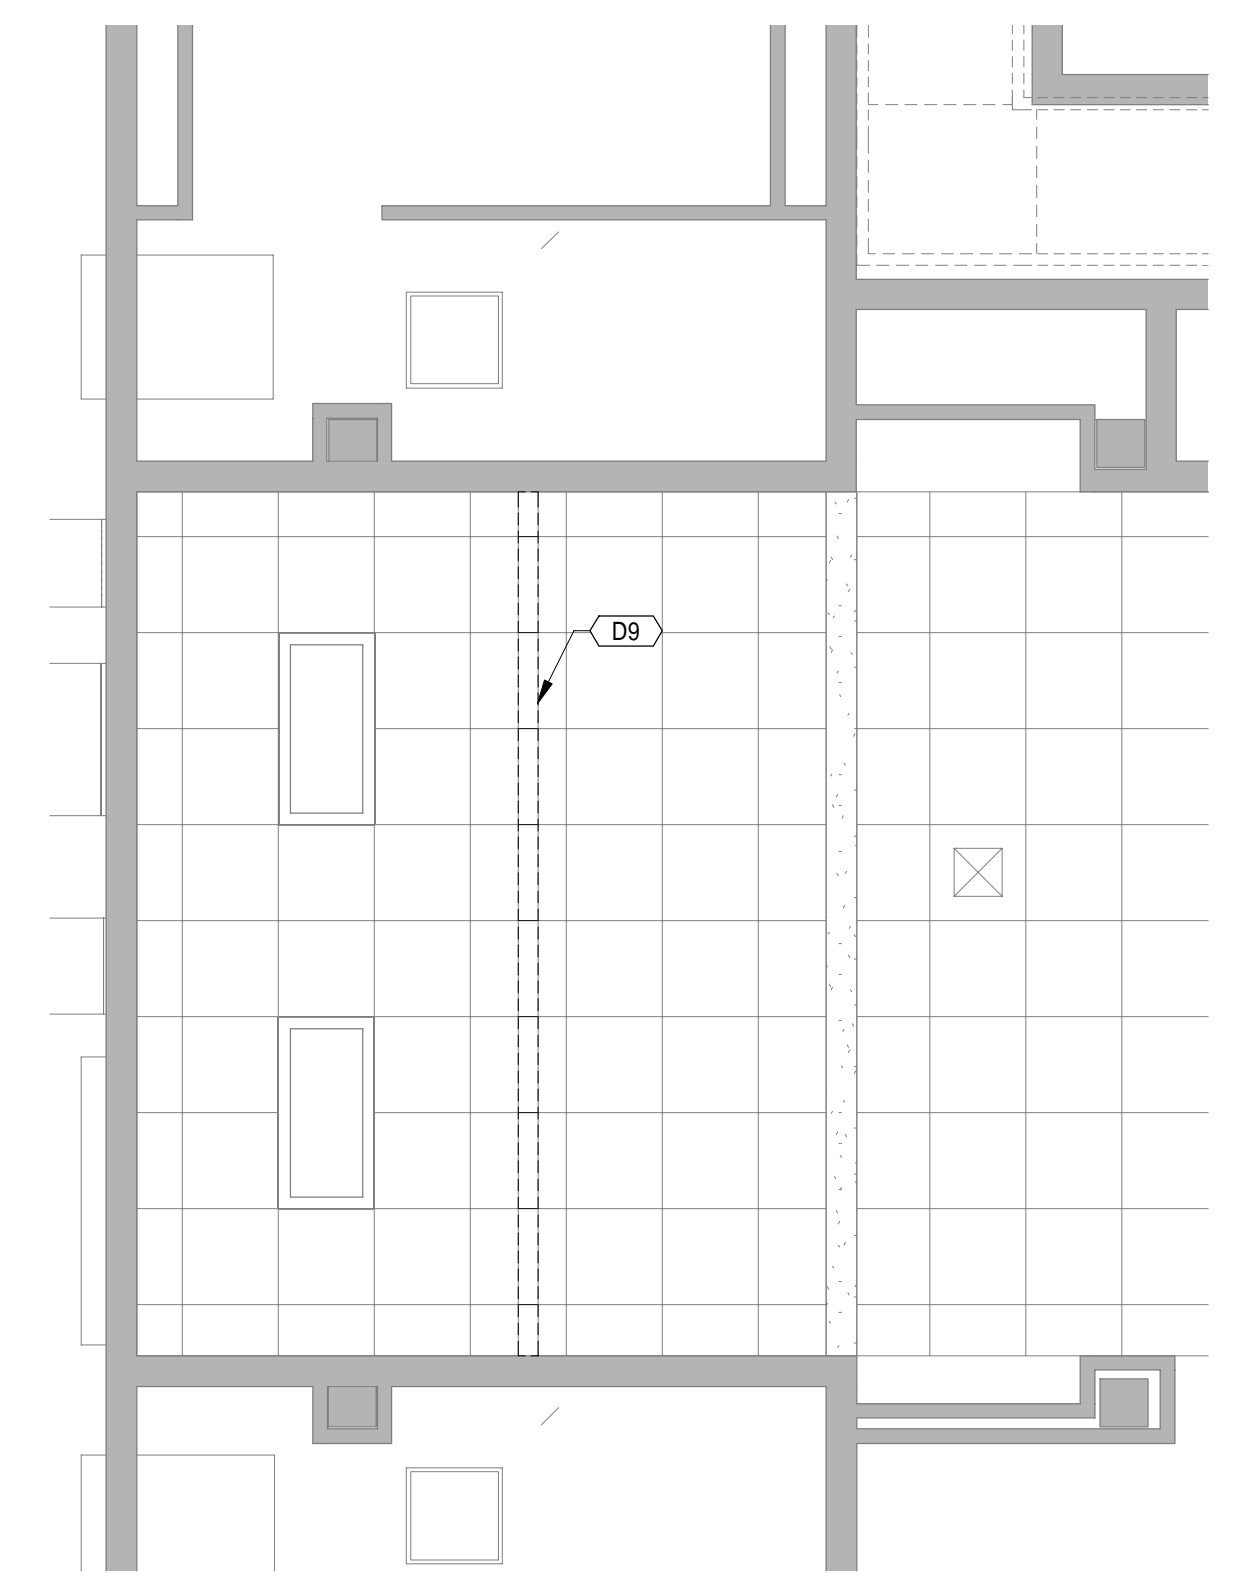


2 Nurse Storage Demo RCP
1/4" = 1'-0"

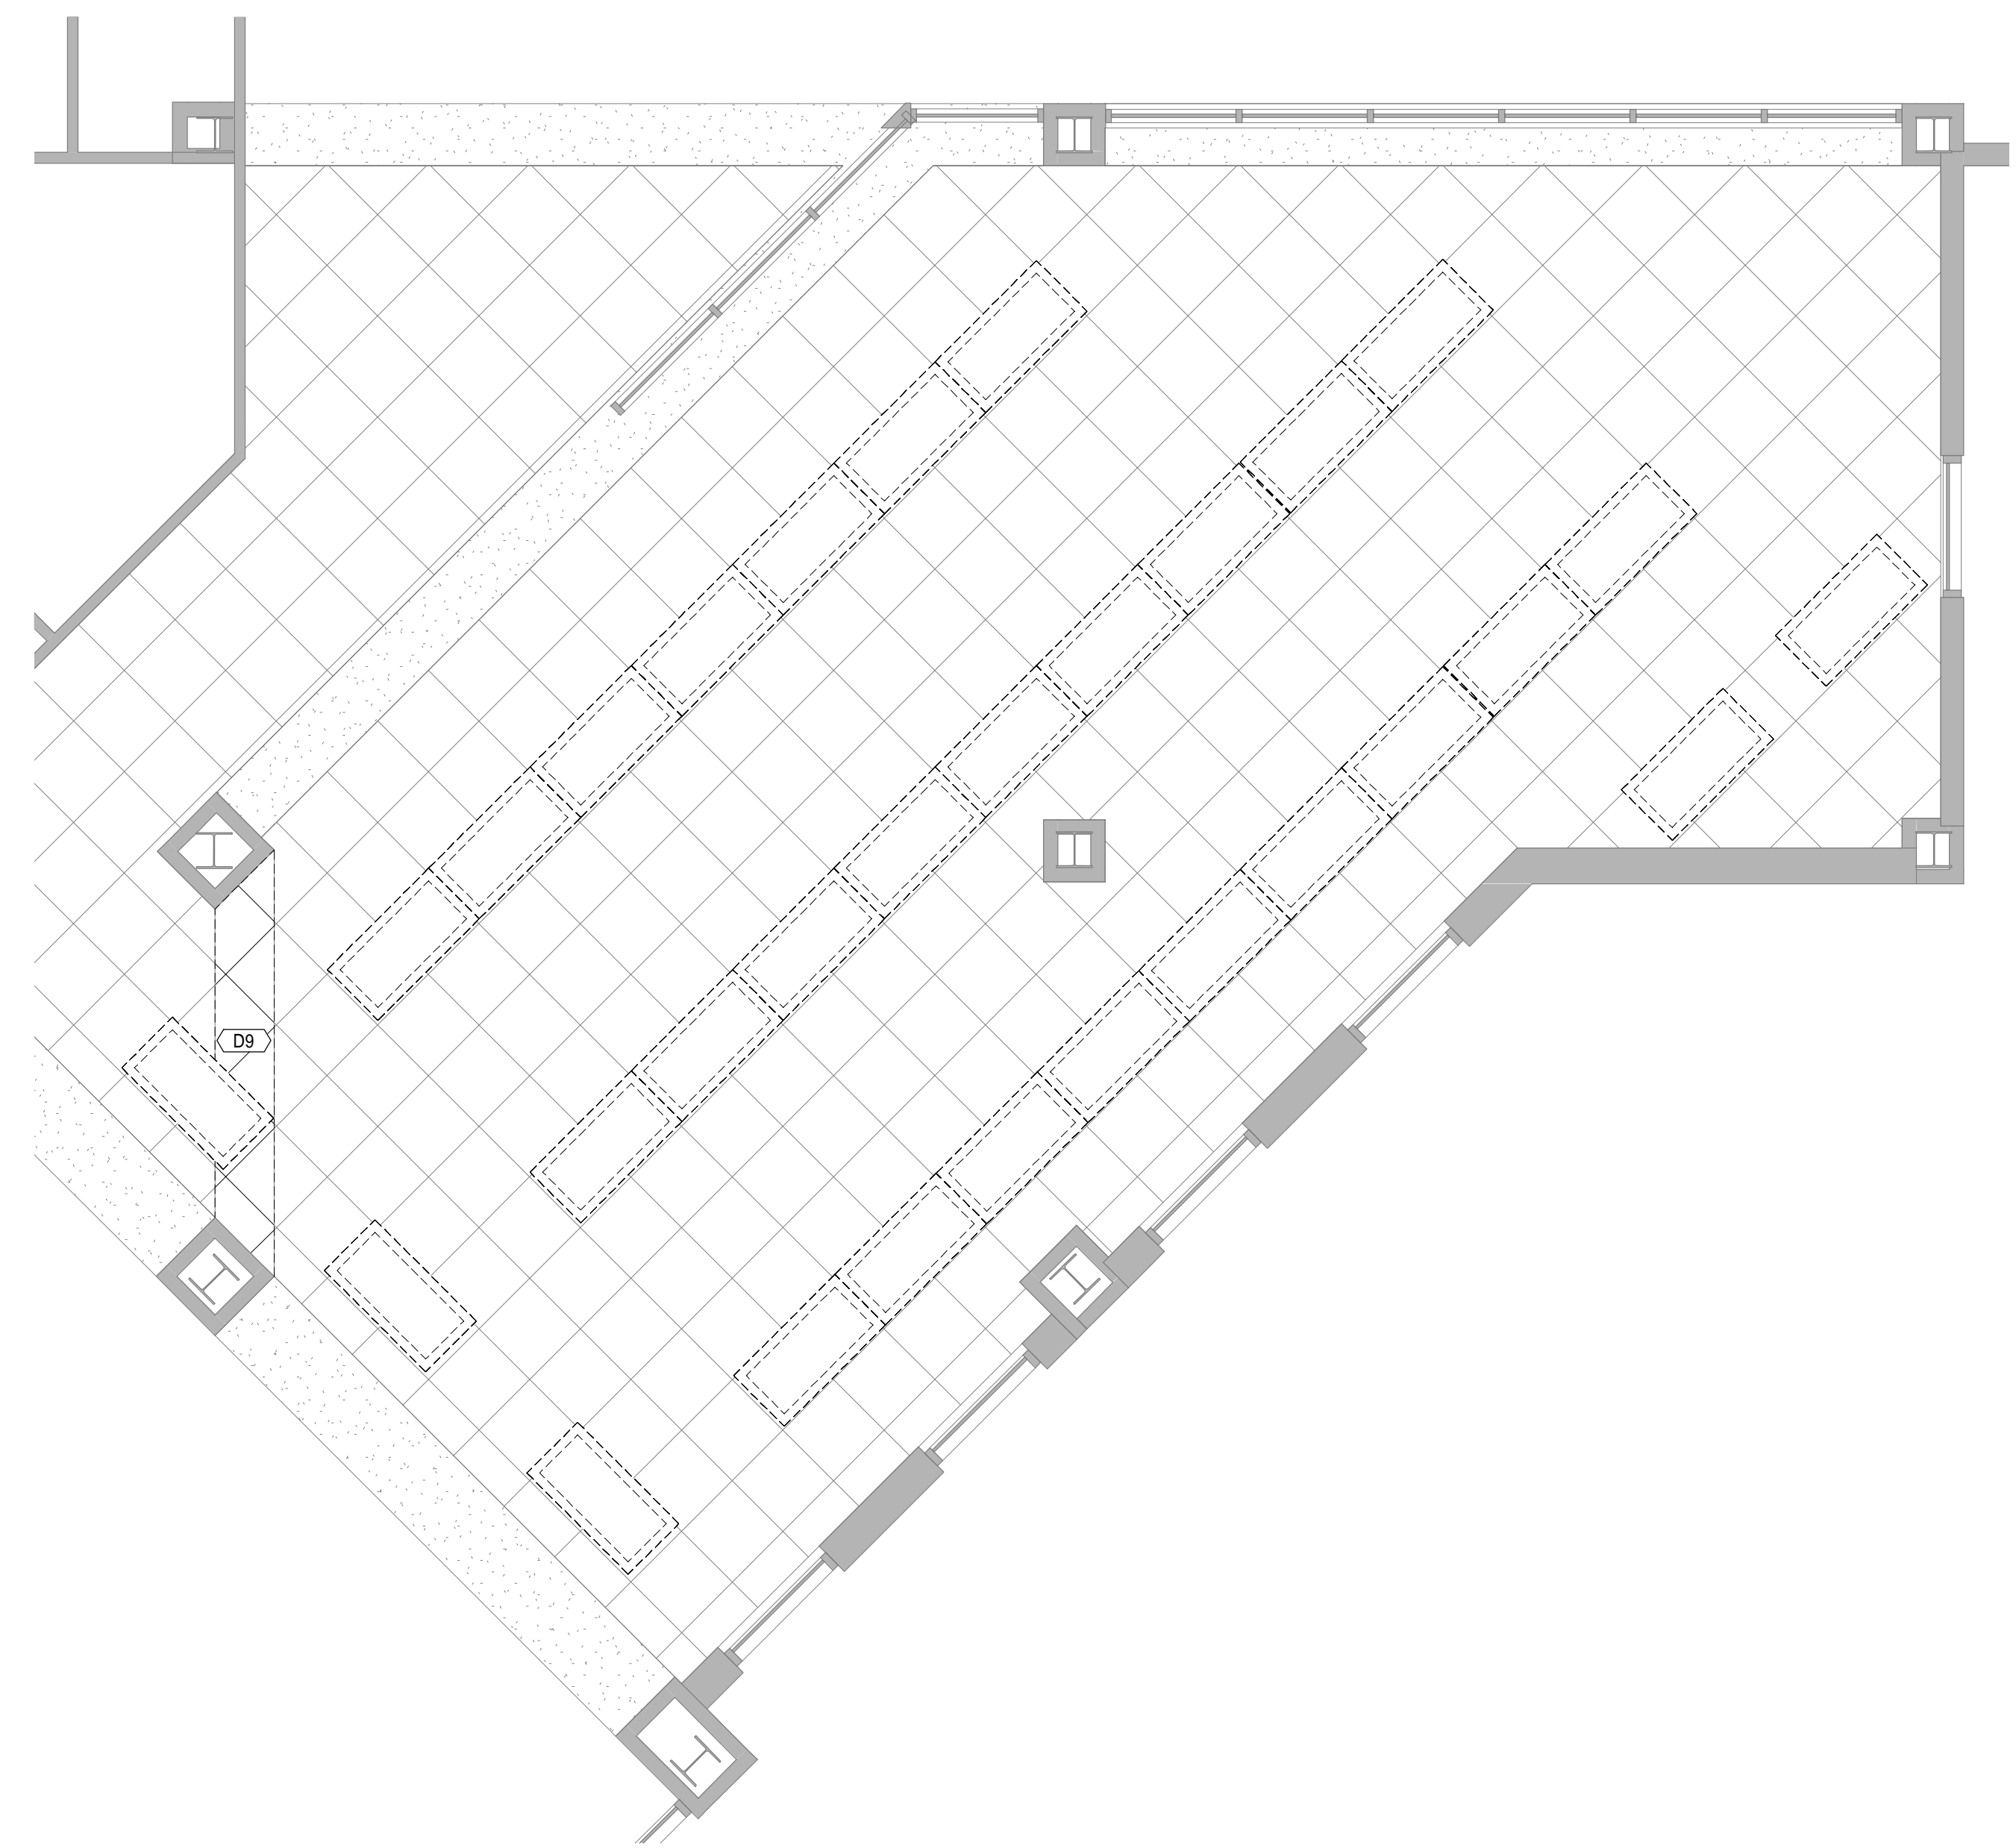

5 Reading Room Demo RCP
1/4" = 1'-0"

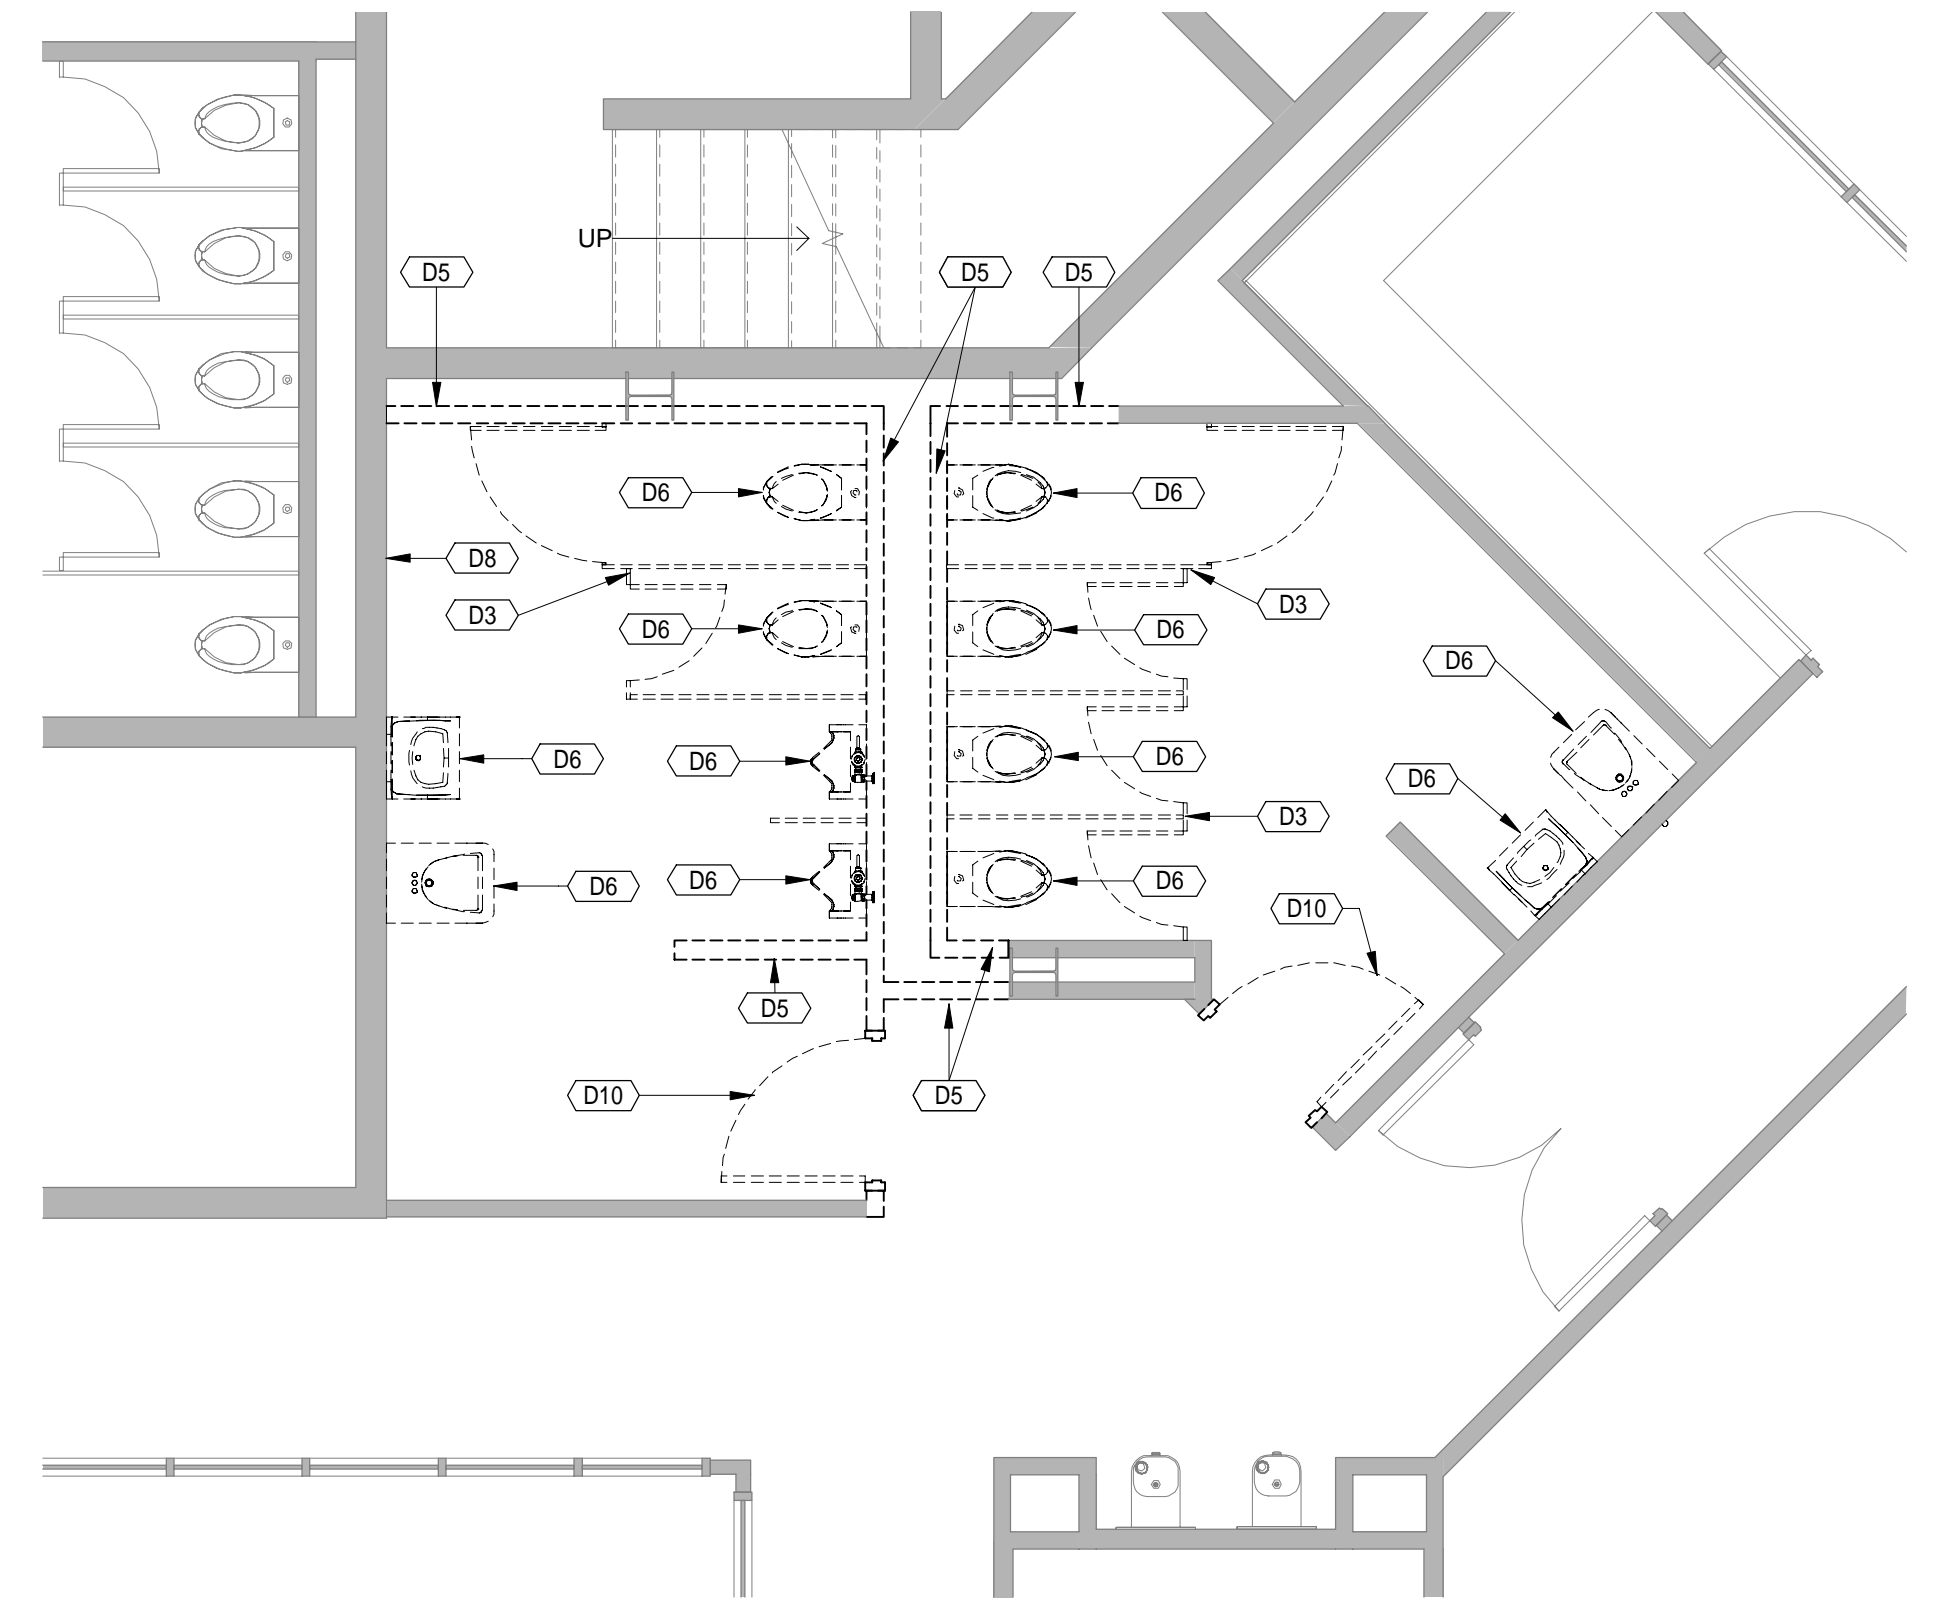

3 Wellness Area Demo Plan
1/4" = 1'-0"

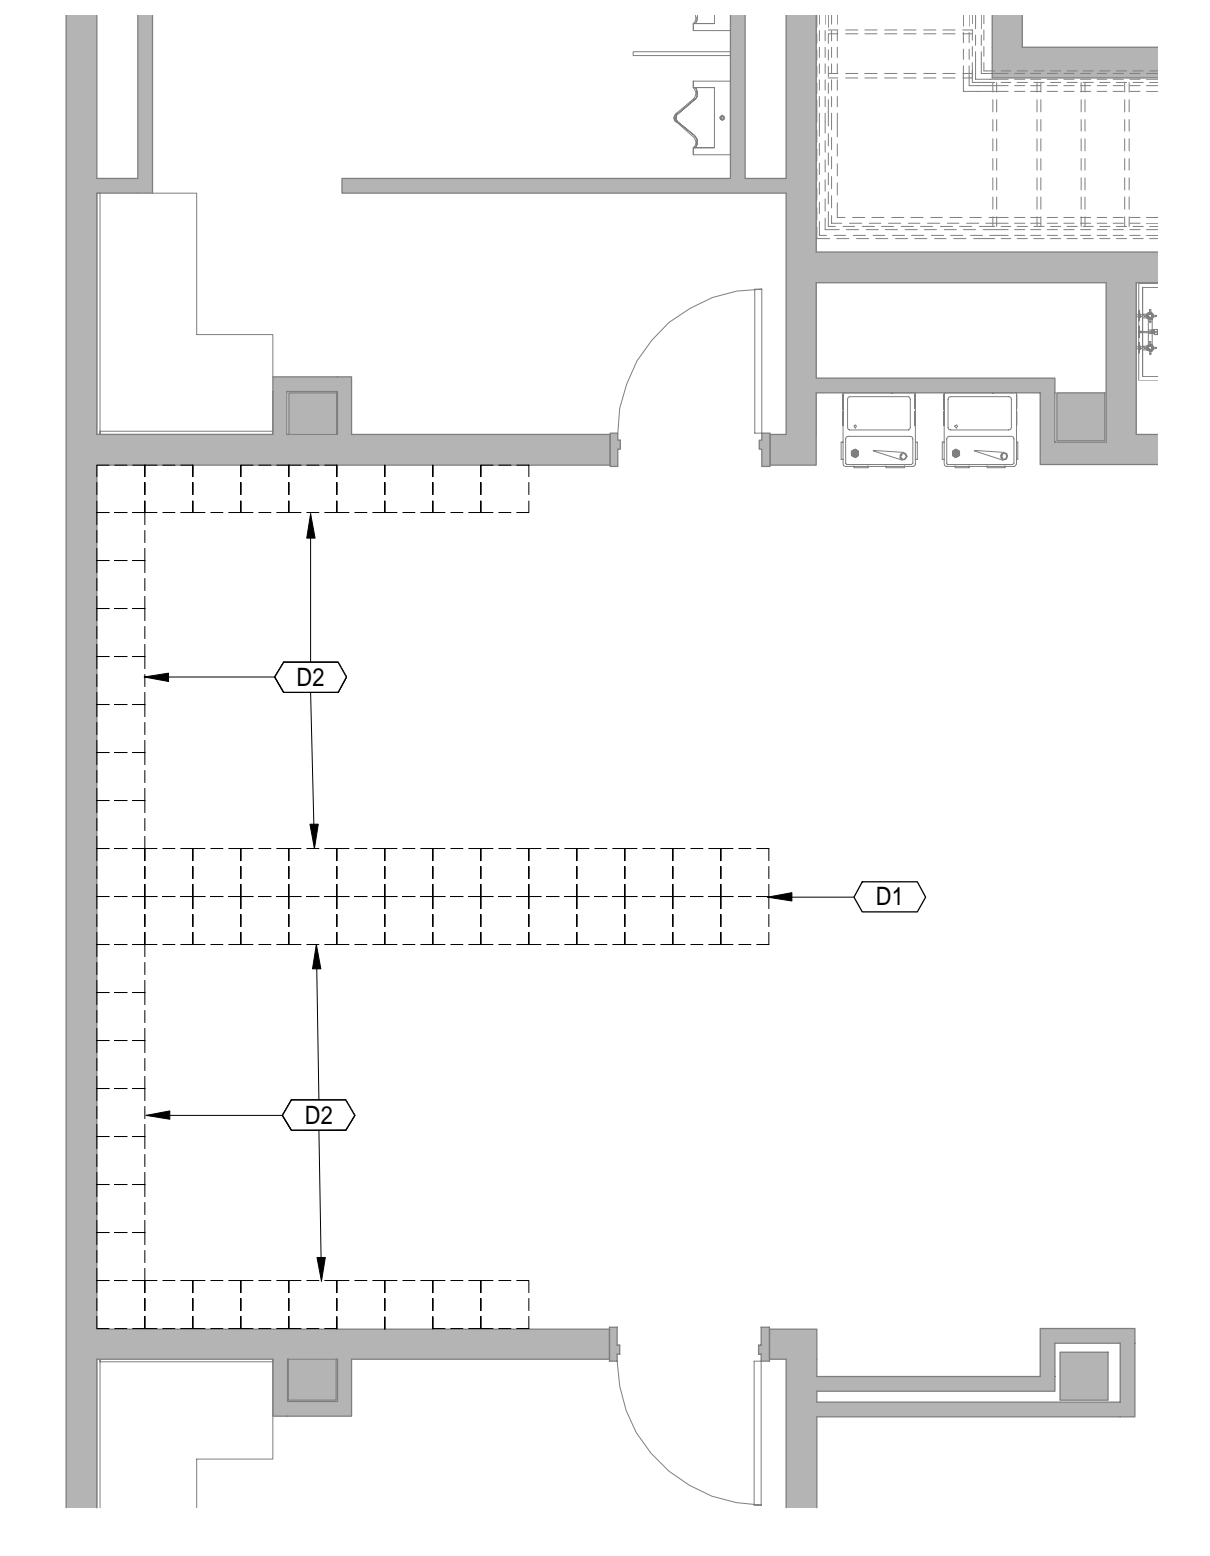

1 Nurse Storage Demo Plan
1/4" = 1'-0"

A Project for:
Indiana University East
Brice E. Hayes Hall
Renovations to Rooms 099, 135, 137, & 140
IU Project Number: 20170750

PROJECT NO. 7327	DATE 10-05-18
REV.	DATE

SET DESCRIPTION
Construction Set

SHEET TITLE
Demolition Plans

SHEET NUMBER

A1-1